

LEGEND

- Limit of Work
- - - Property Line
- Planting Bed
- ▭ Bench
- Pop-up Spray Heads (Beds)
- Lawn Rotors
- Pop-up Spray Heads (Lawn)
- Controller Location - nine zone Irritrol, total control.
- ⊗ Shut-off & Supply Valve for fountain.
- ⚡ 1 1/2" Solenoid Valve

Irrigation Designer: Eljay Irrigation Ltd. Victoria, BC tel: 544-0401
 Irrigation Contractor: Aqua Irrigation Ltd. Victoria, BC tel: 652-9293

No.	Date	Issued For	By
1	Feb. 02/02	As-built	

COPYRIGHT RESERVED. THESE PLANS AND DESIGN ARE AT ALL TIMES THE PROPERTY OF THE DESIGNER TO BE USED FOR THE PROJECT SHOWN. WRITTEN CONSENT IS REQUIRED FROM THE DESIGNER BEFORE ANY REPRODUCTION.

The District of Langford
 client

Veteran's Park
 project title

Irrigation Plan
 drawing title


design/drawn by: _____ date: _____
 checked by: _____ scale: 1:250


100.12 project no. LA.01 drawing no.

GH0320

VETERAN'S PARK

 PARKS



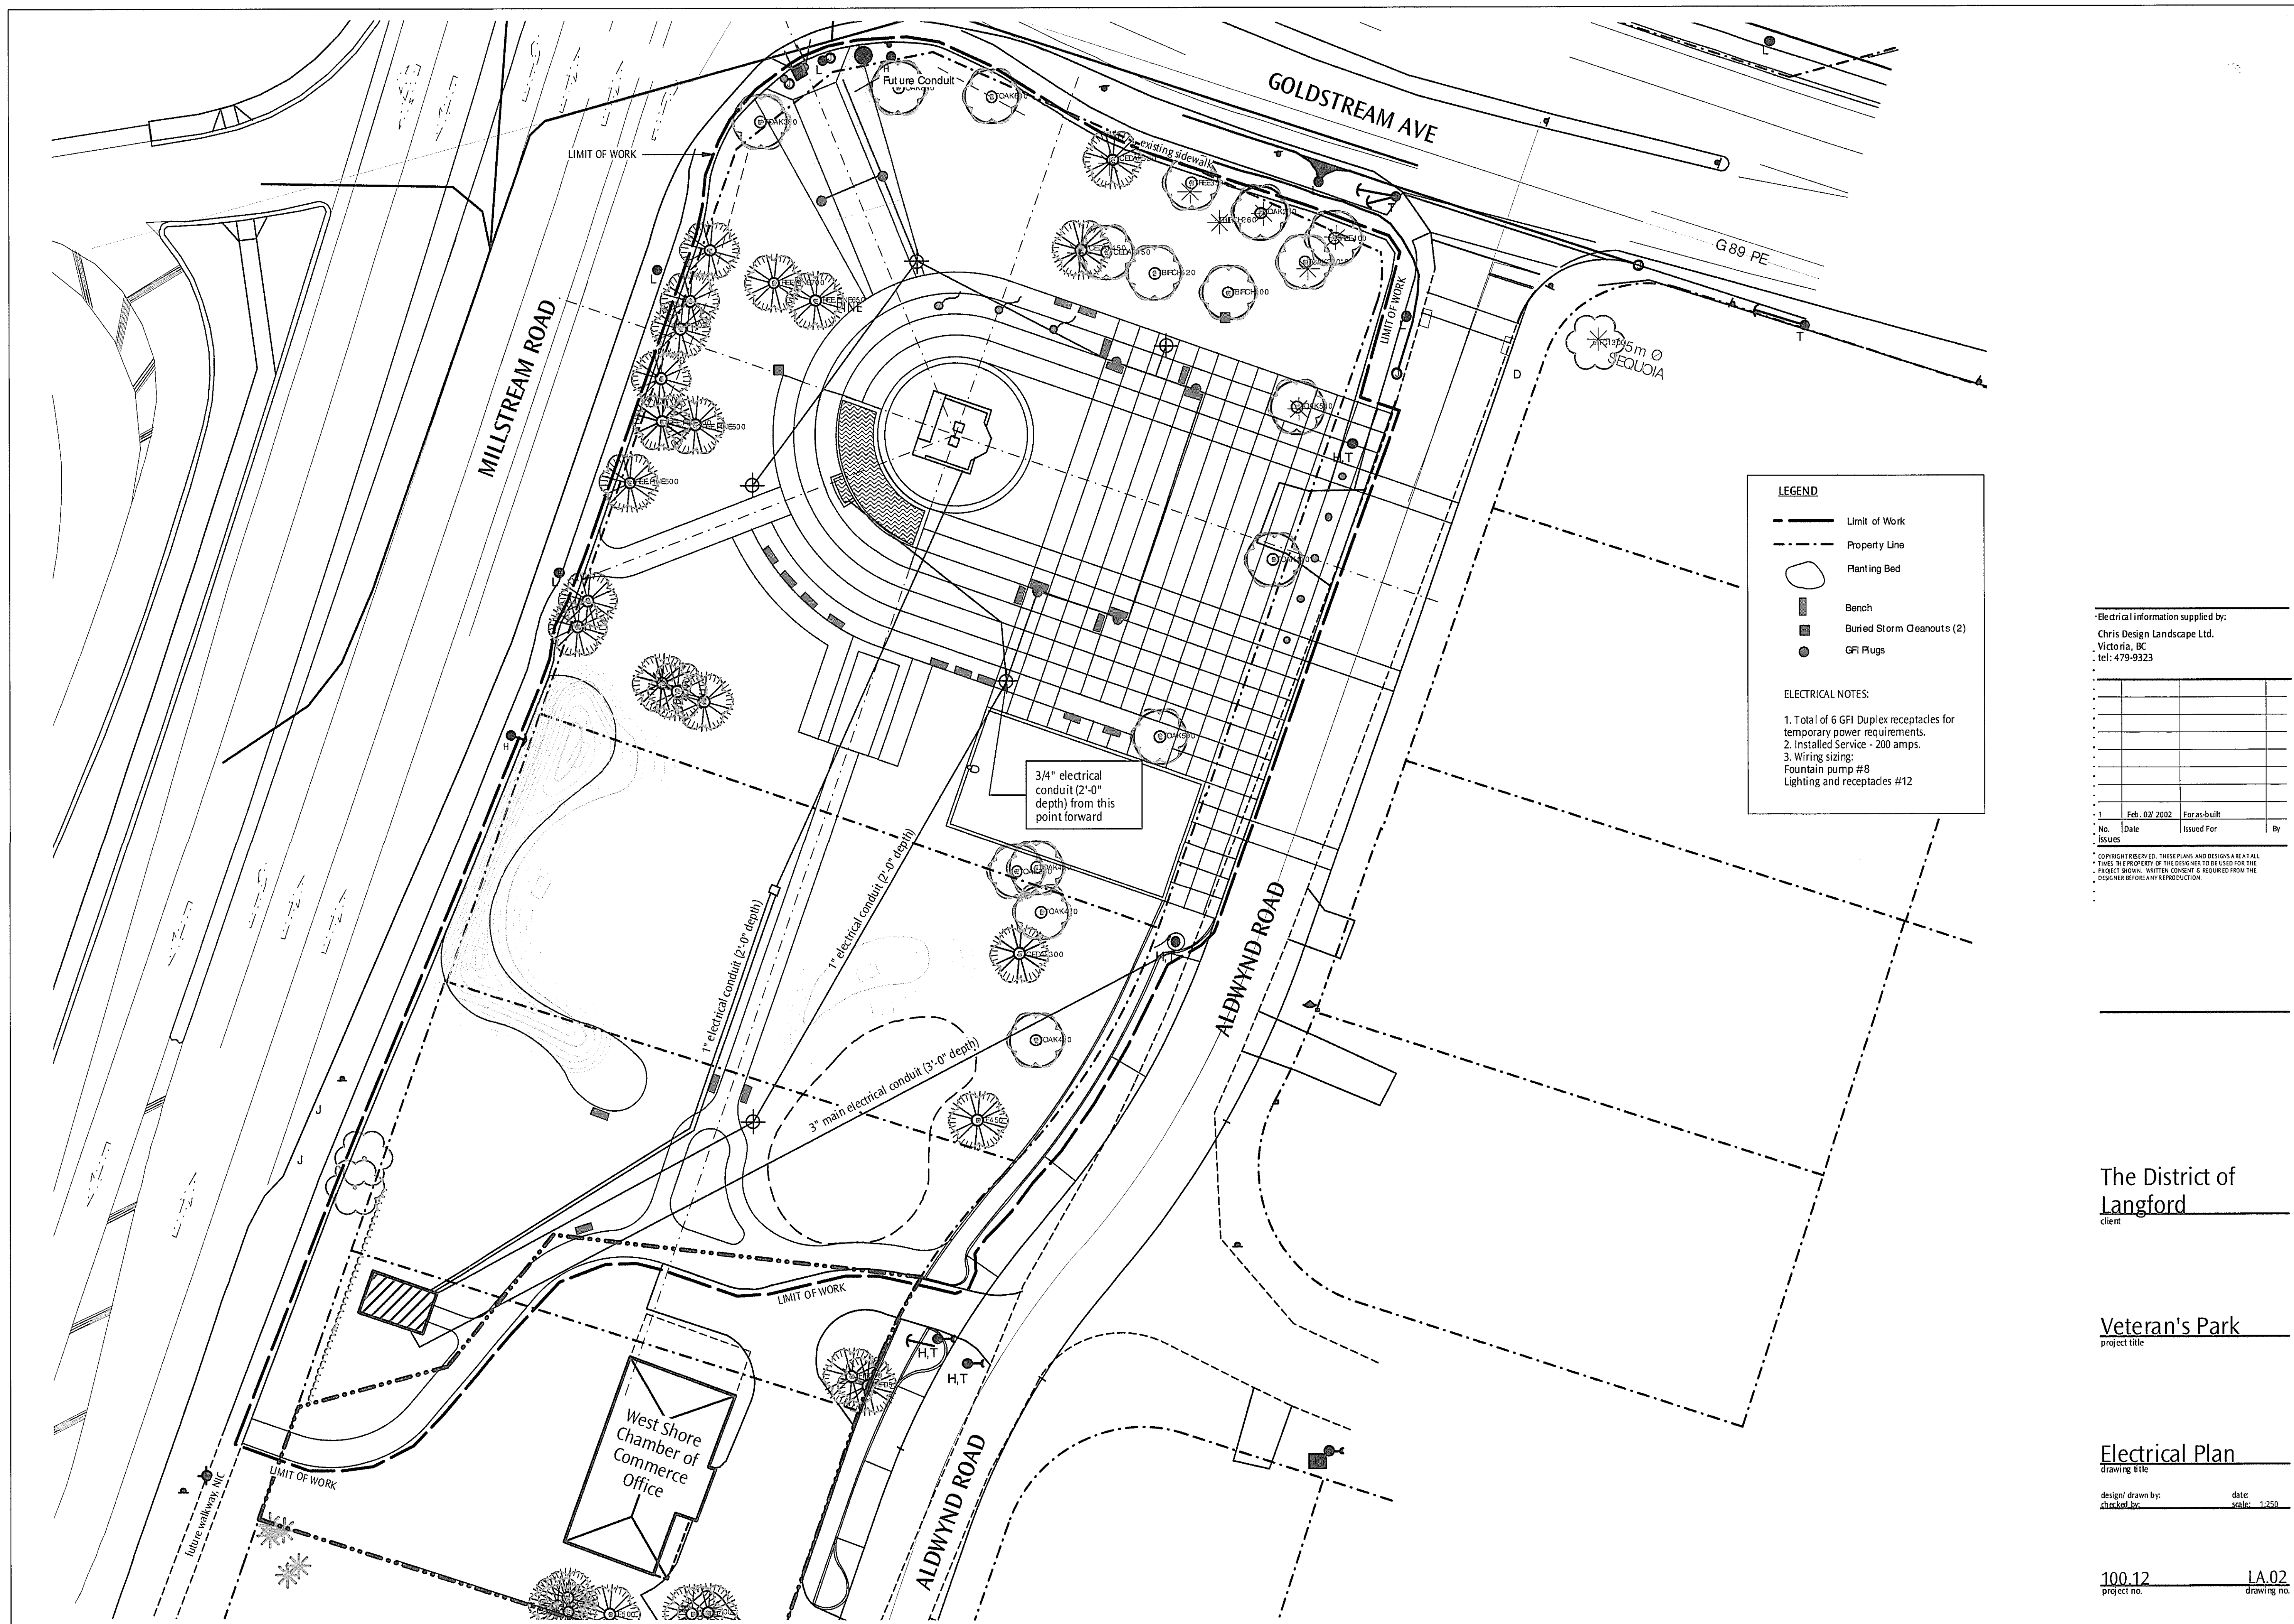

LEGEND

- Limit of Work
- - - Property Line
- Planting Bed
- ▭ Bench
- Buried Storm Cleanouts (2)
- GFI Plugs

ELECTRICAL NOTES:

1. Total of 6 GFI Duplex receptacles for temporary power requirements.
2. Installed Service - 200 amps.
3. Wiring sizing:
Fountain pump #8
Lighting and receptacles #12

Electrical information supplied by:
Chris Design Landscape Ltd.
Victoria, BC
tel: 479-9323

No.	Date	Issued For	By
1	Feb. 02 2002	For as-built	

* COPYRIGHT RESERVED. THESE PLANS AND DESIGNS ARE AT ALL TIMES THE PROPERTY OF THE DESIGNER AND ARE NOT TO BE REPRODUCED OR USED FOR ANY OTHER PROJECT WITHOUT THE WRITTEN CONSENT OF THE DESIGNER BEFORE ANY REPRODUCTION.

The District of
Langford
client

Veteran's Park
project title

Electrical Plan
drawing title

design/drawn by: _____ date: _____
checked by: _____ scale: 1:250

100.12 project no. LA.02 drawing no.

640321